


NOTES

•

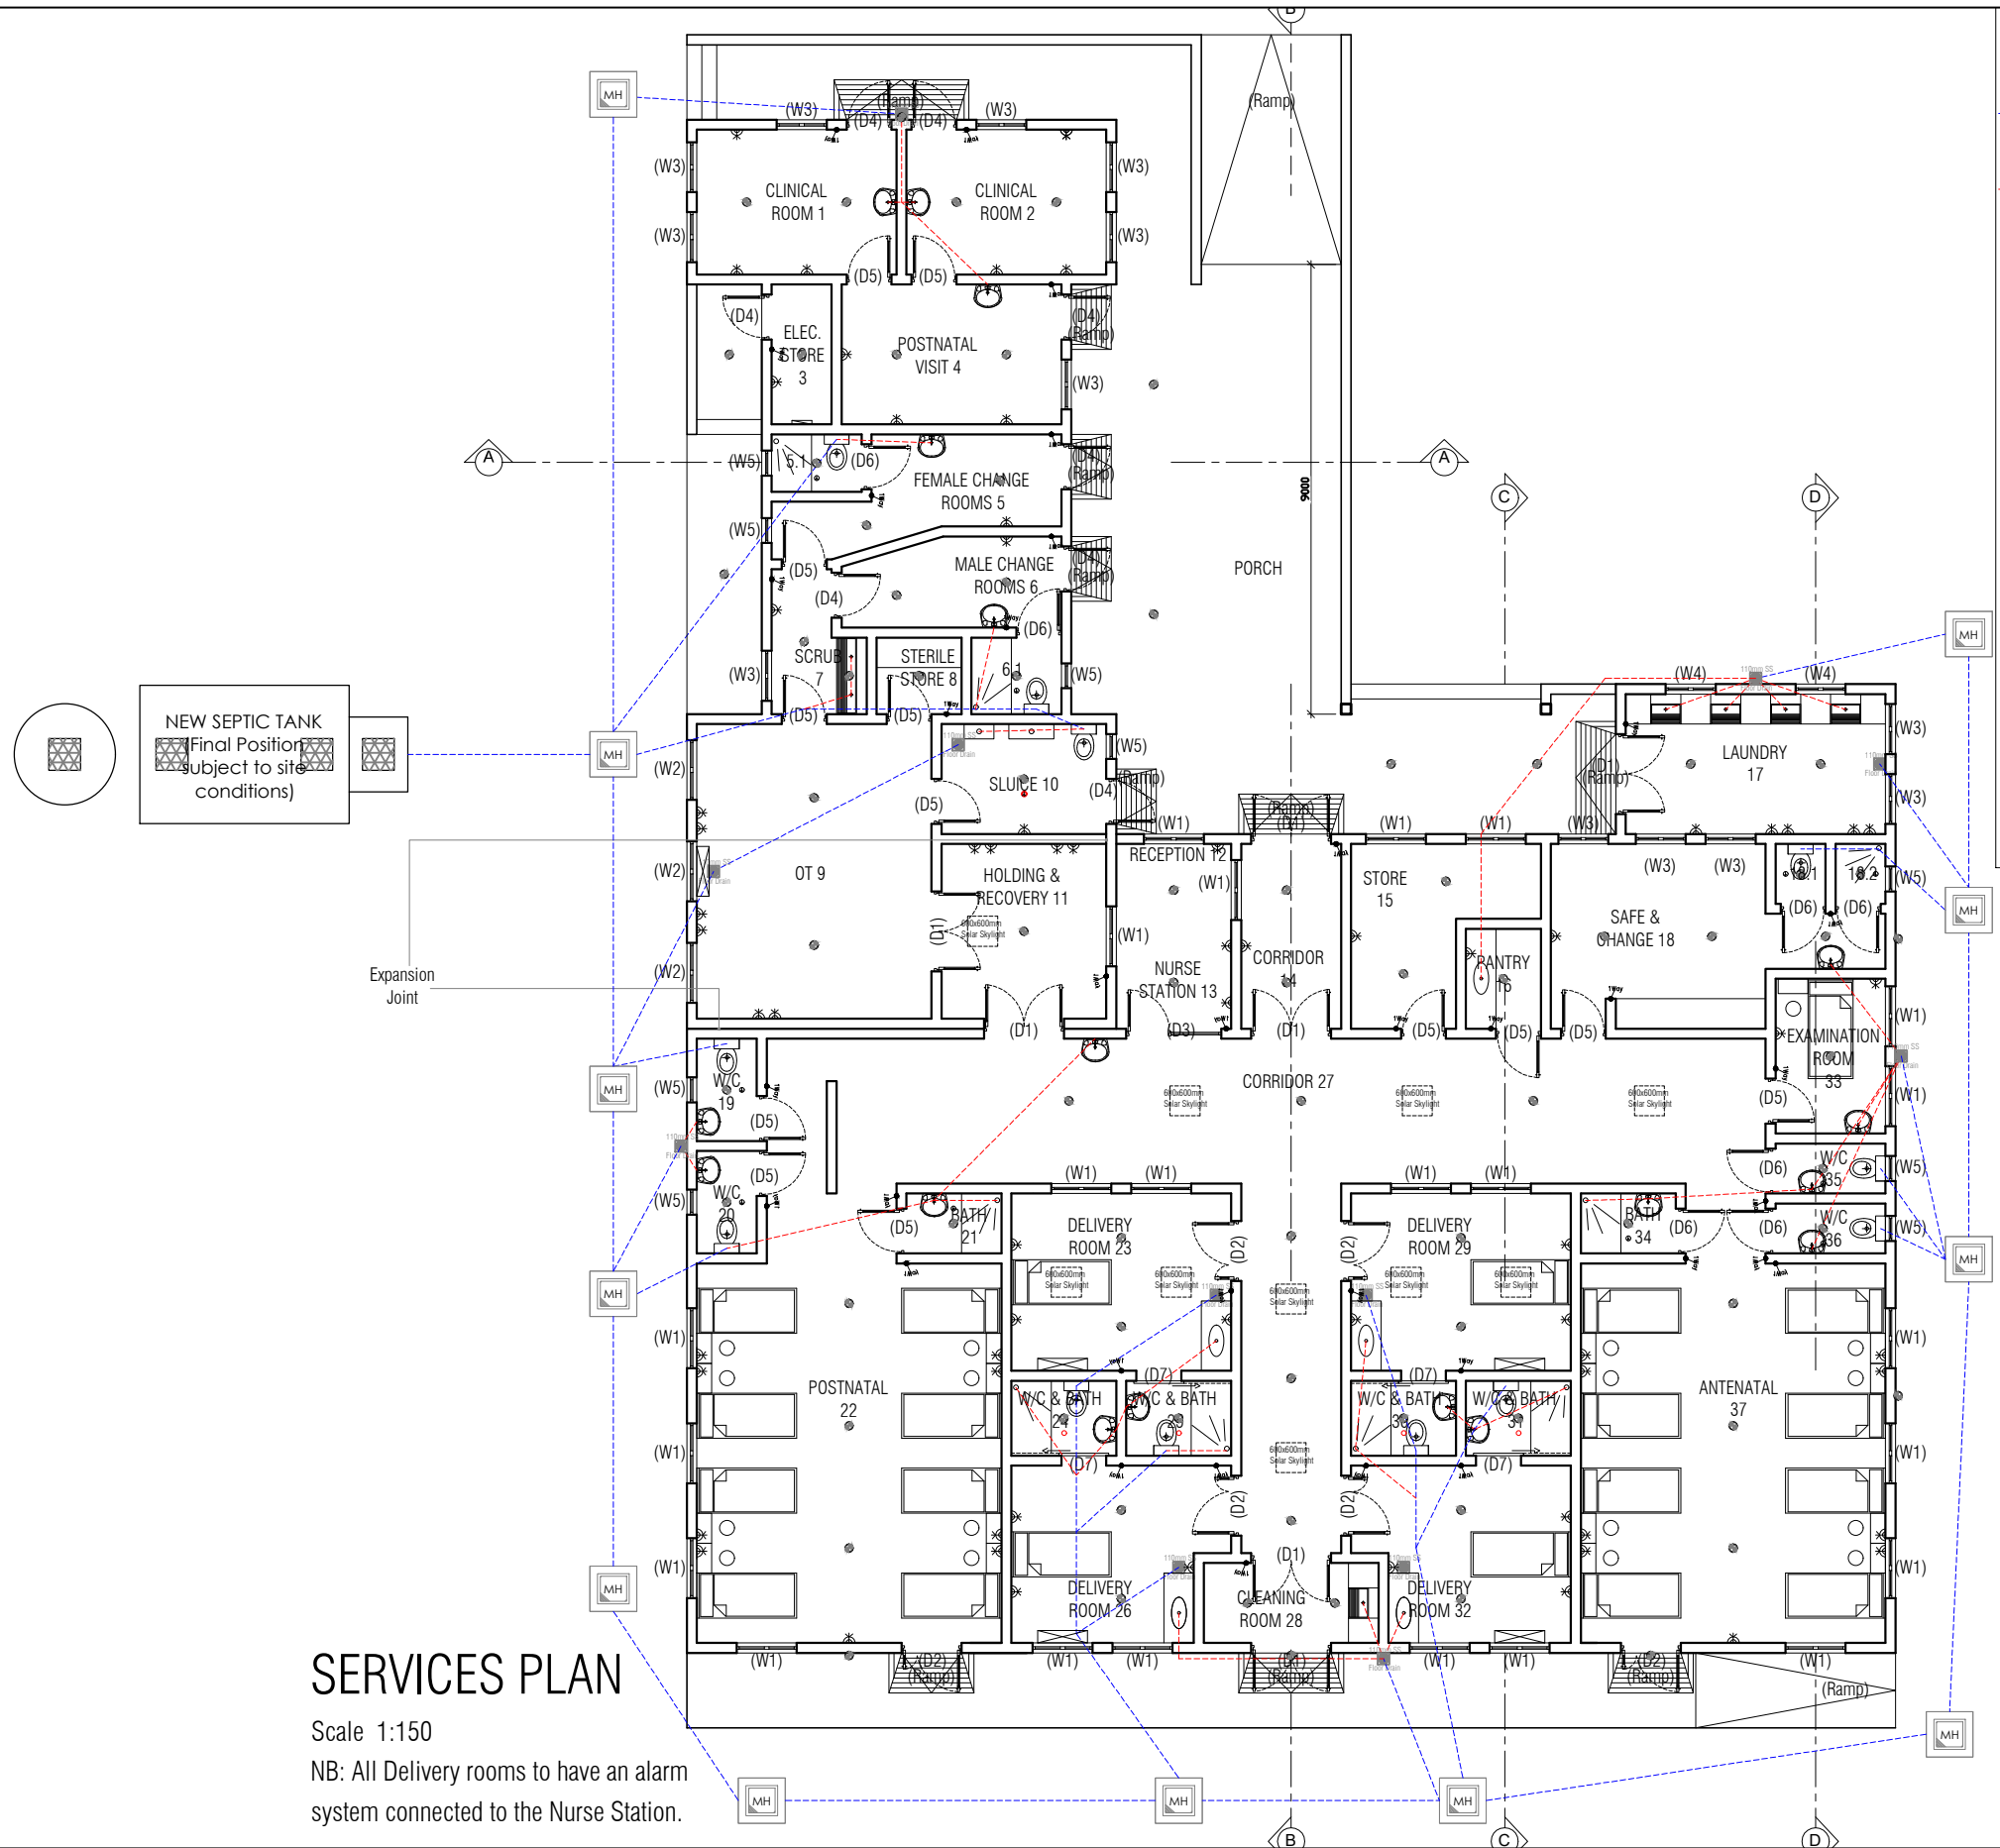

110mm Ø PVC
50mm Ø PVC

ELECTRICAL LEGEND

	DOUBLE WALL SOCKET
	DISTRIBUTION BOARD
	EXTRACTOR FAN
	AIR CONDITIONING UNIT

LIGHTING LEGEND

SYMBOL	DESCRIPTION
	LIGHT POINT
	SWITCH POINTS=1 LEVER
	2 WAY SWITCH

NEW SEPTIC TANK
Final Position
subject to site
conditions

SERVICES PLAN

Scale 1:150

NB: All Delivery rooms to have an alarm system connected to the Nurse Station.



Stichting Bouwen (The Gambia)

Project name: Proposed Maternity Ward, Brufut Health Centre, Gambia

Projectnumber: 2019-243